
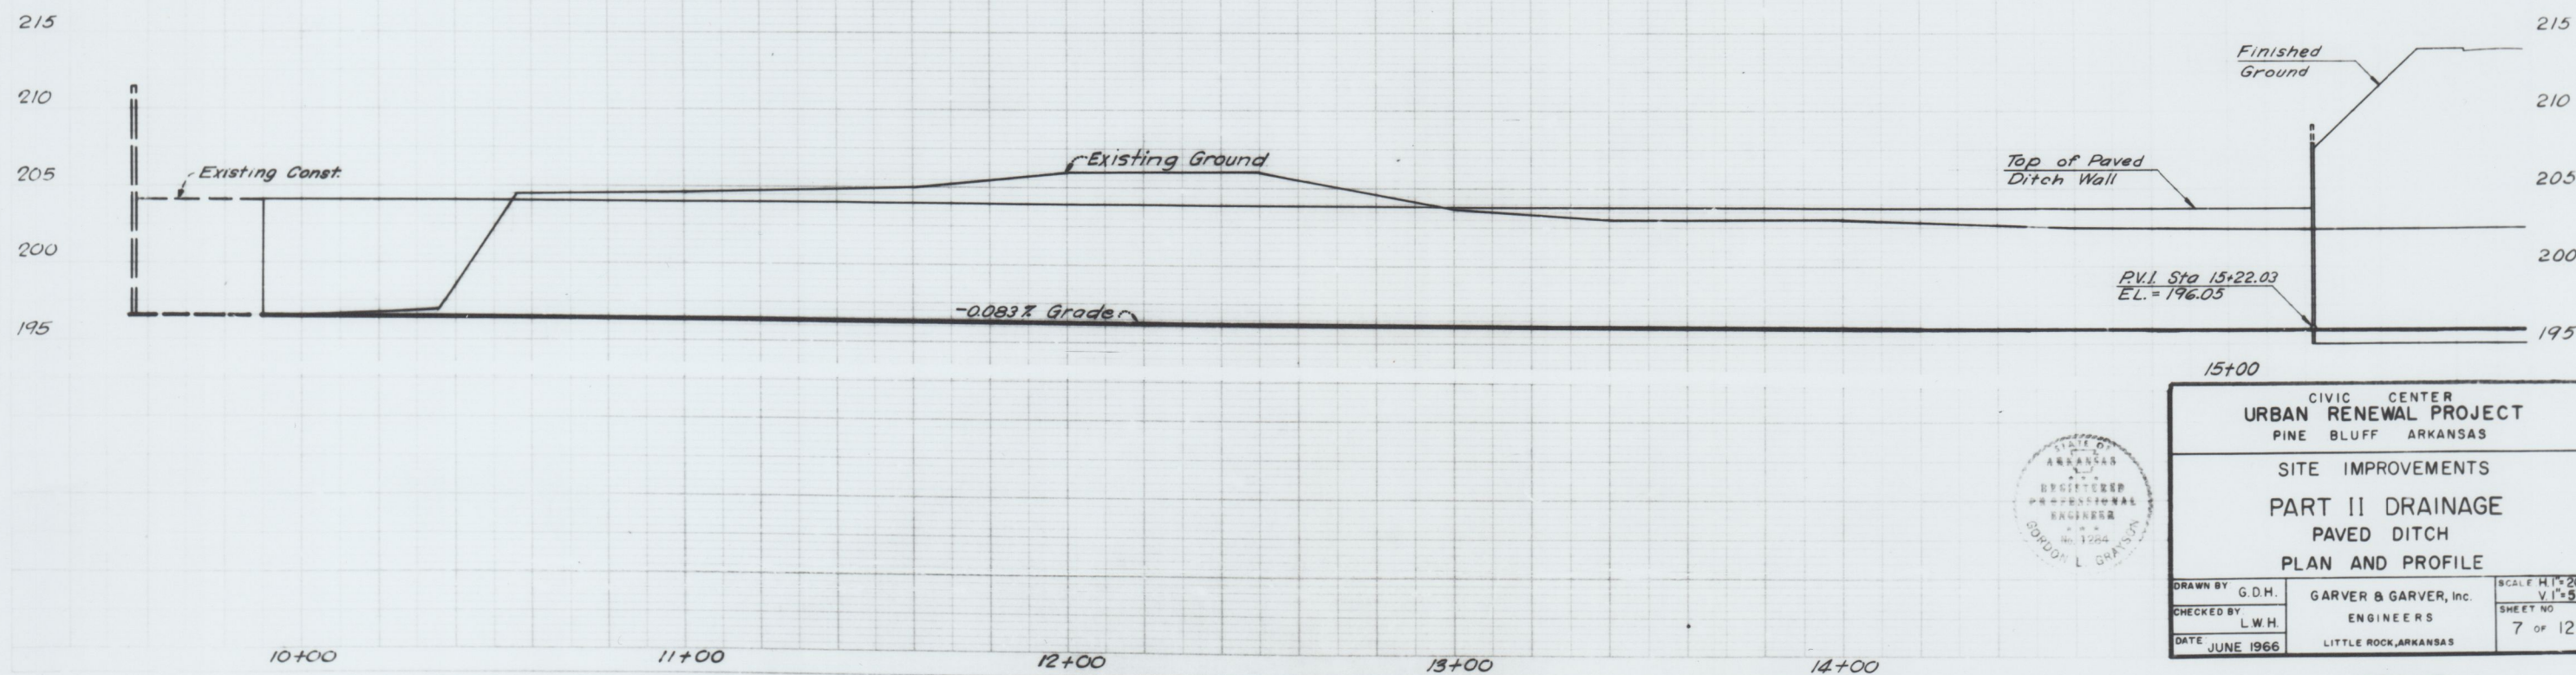


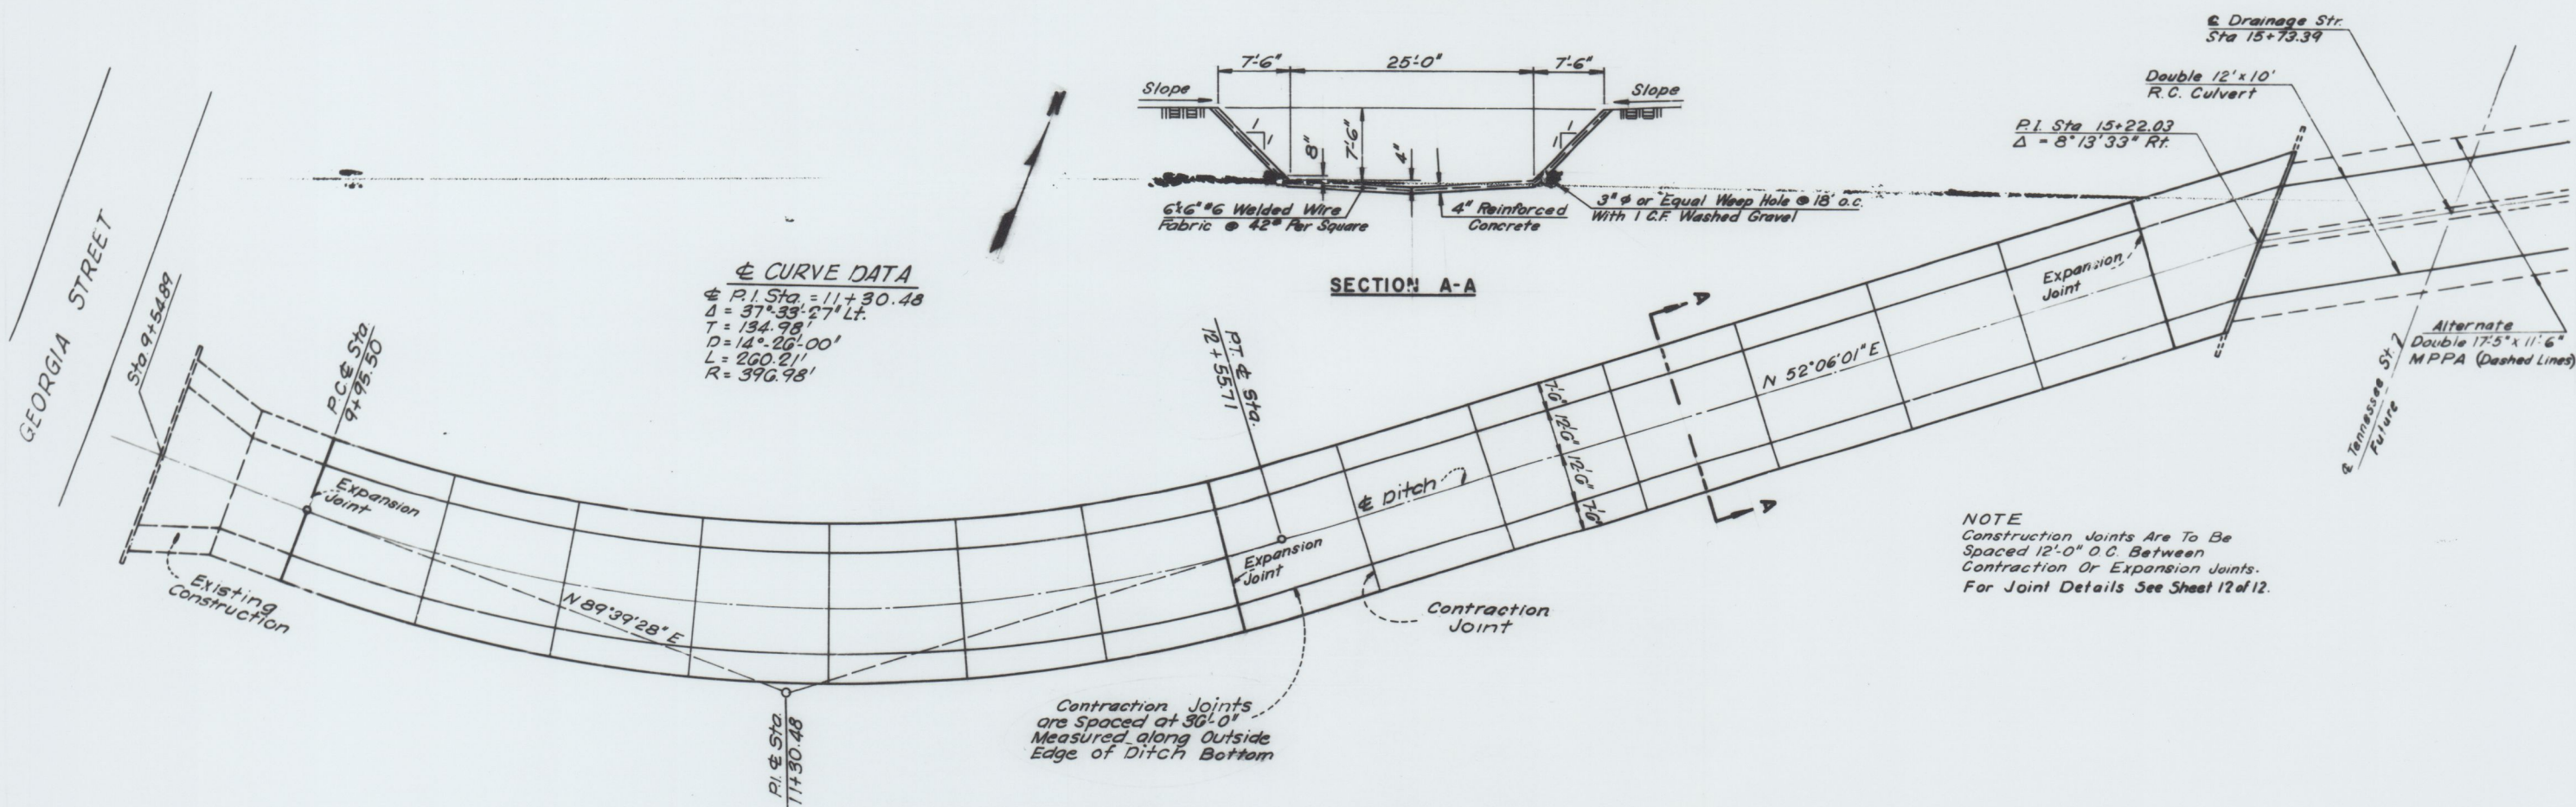

CIVIC CENTER URBAN RENEWAL PROJECT PINE BLUFF ARKANSAS	
SITE IMPROVEMENTS	
PART II DRAINAGE PAVED DITCH PLAN AND PROFILE	
DRAWN BY G.D.H.	GARVER & GARVER, Inc.
CHECKED BY L.W.H.	ENGINEERS
DATE JUNE 1966	LITTLE ROCK, ARKANSAS
SCALE H 1"=20' V 1"=5'	SHEET NO. 7 OF 12

126/010