


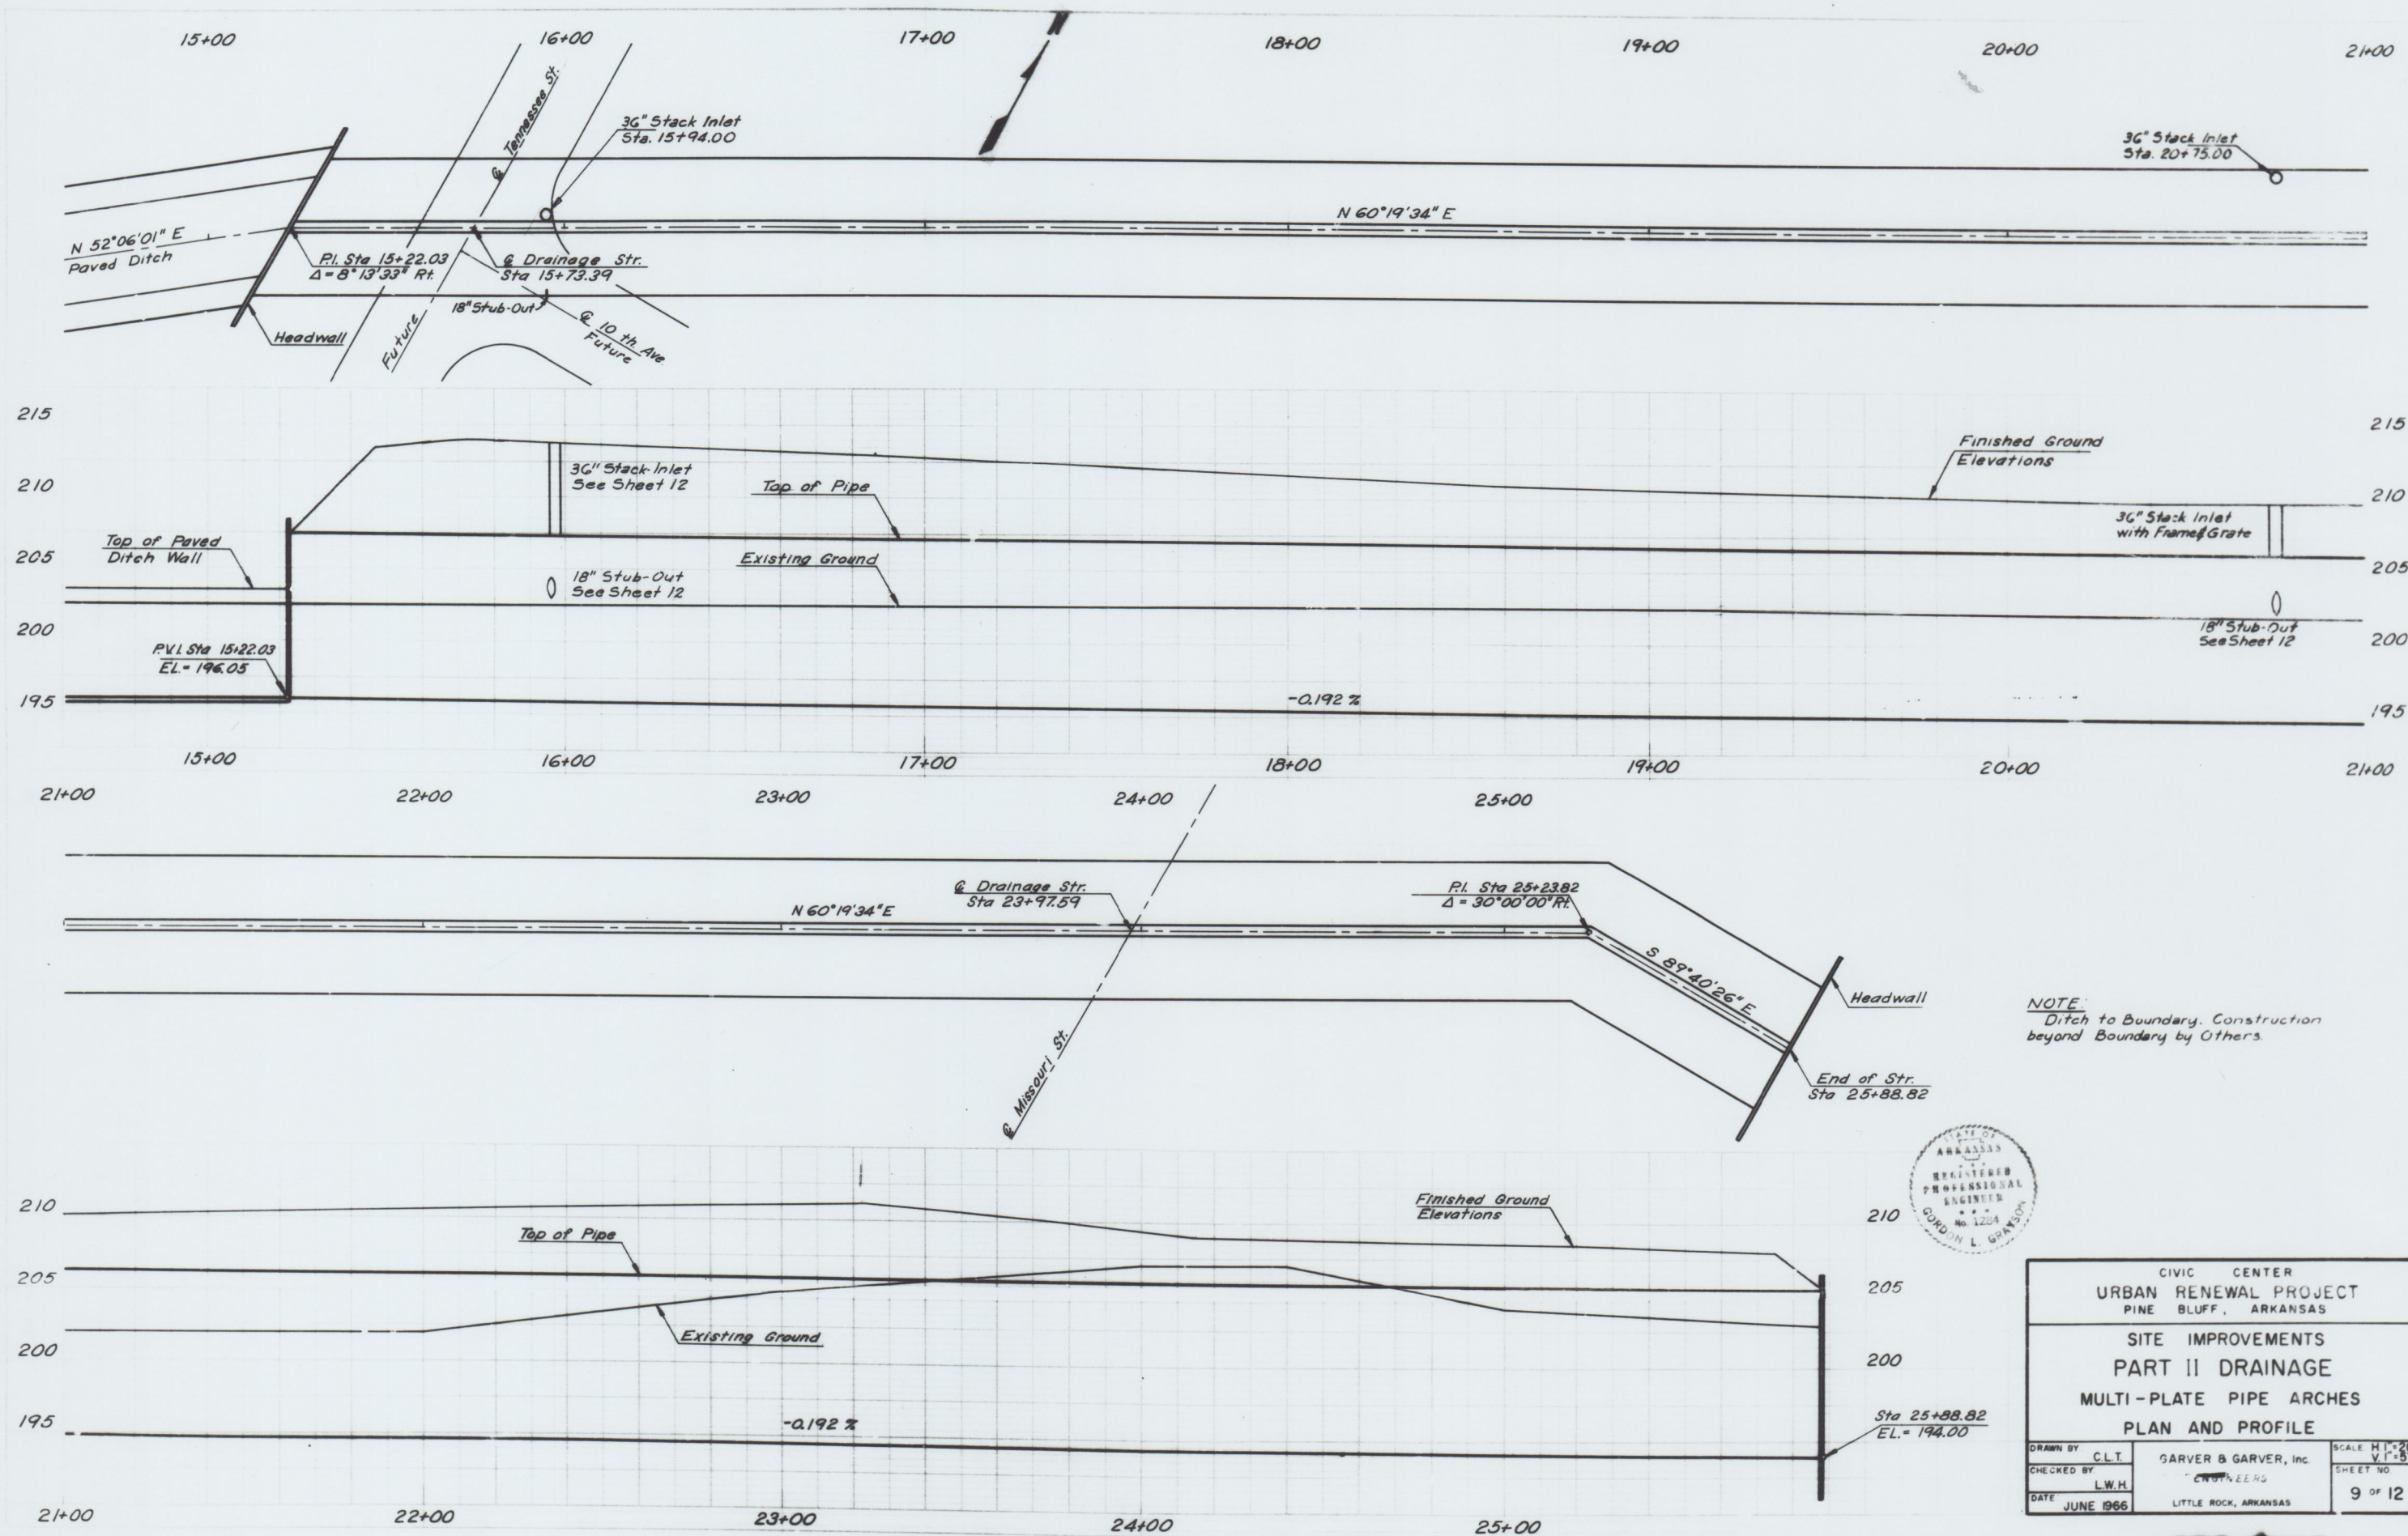

CIVIC CENTER URBAN RENEWAL PROJECT PINE BLUFF, ARKANSAS			
SITE IMPROVEMENTS PART II DRAINAGE MULTI-PLATE PIPE ARCHES PLAN AND PROFILE			
DRAWN BY CLT	GARVER & GARVER, Inc.		SCALE H1=20 V1=5
CHECKED BY L.W.H.	ENGINEERS		SHEET NO.
DATE JUNE 1966	LITTLE ROCK, ARKANSAS		9 OF 12

126/012