

- CITY HALL
- POLICE & FIRE DEPT.
- LIBRARY—ARTS & SCIENCES

EDWARD DURELL STONE
NEW YORK, N. Y.

REED & WILLIS
PINE BLUFF, ARK.




JOB NO. 65-170

DATE AUGUST 10, 1962

SHEET NO.

2

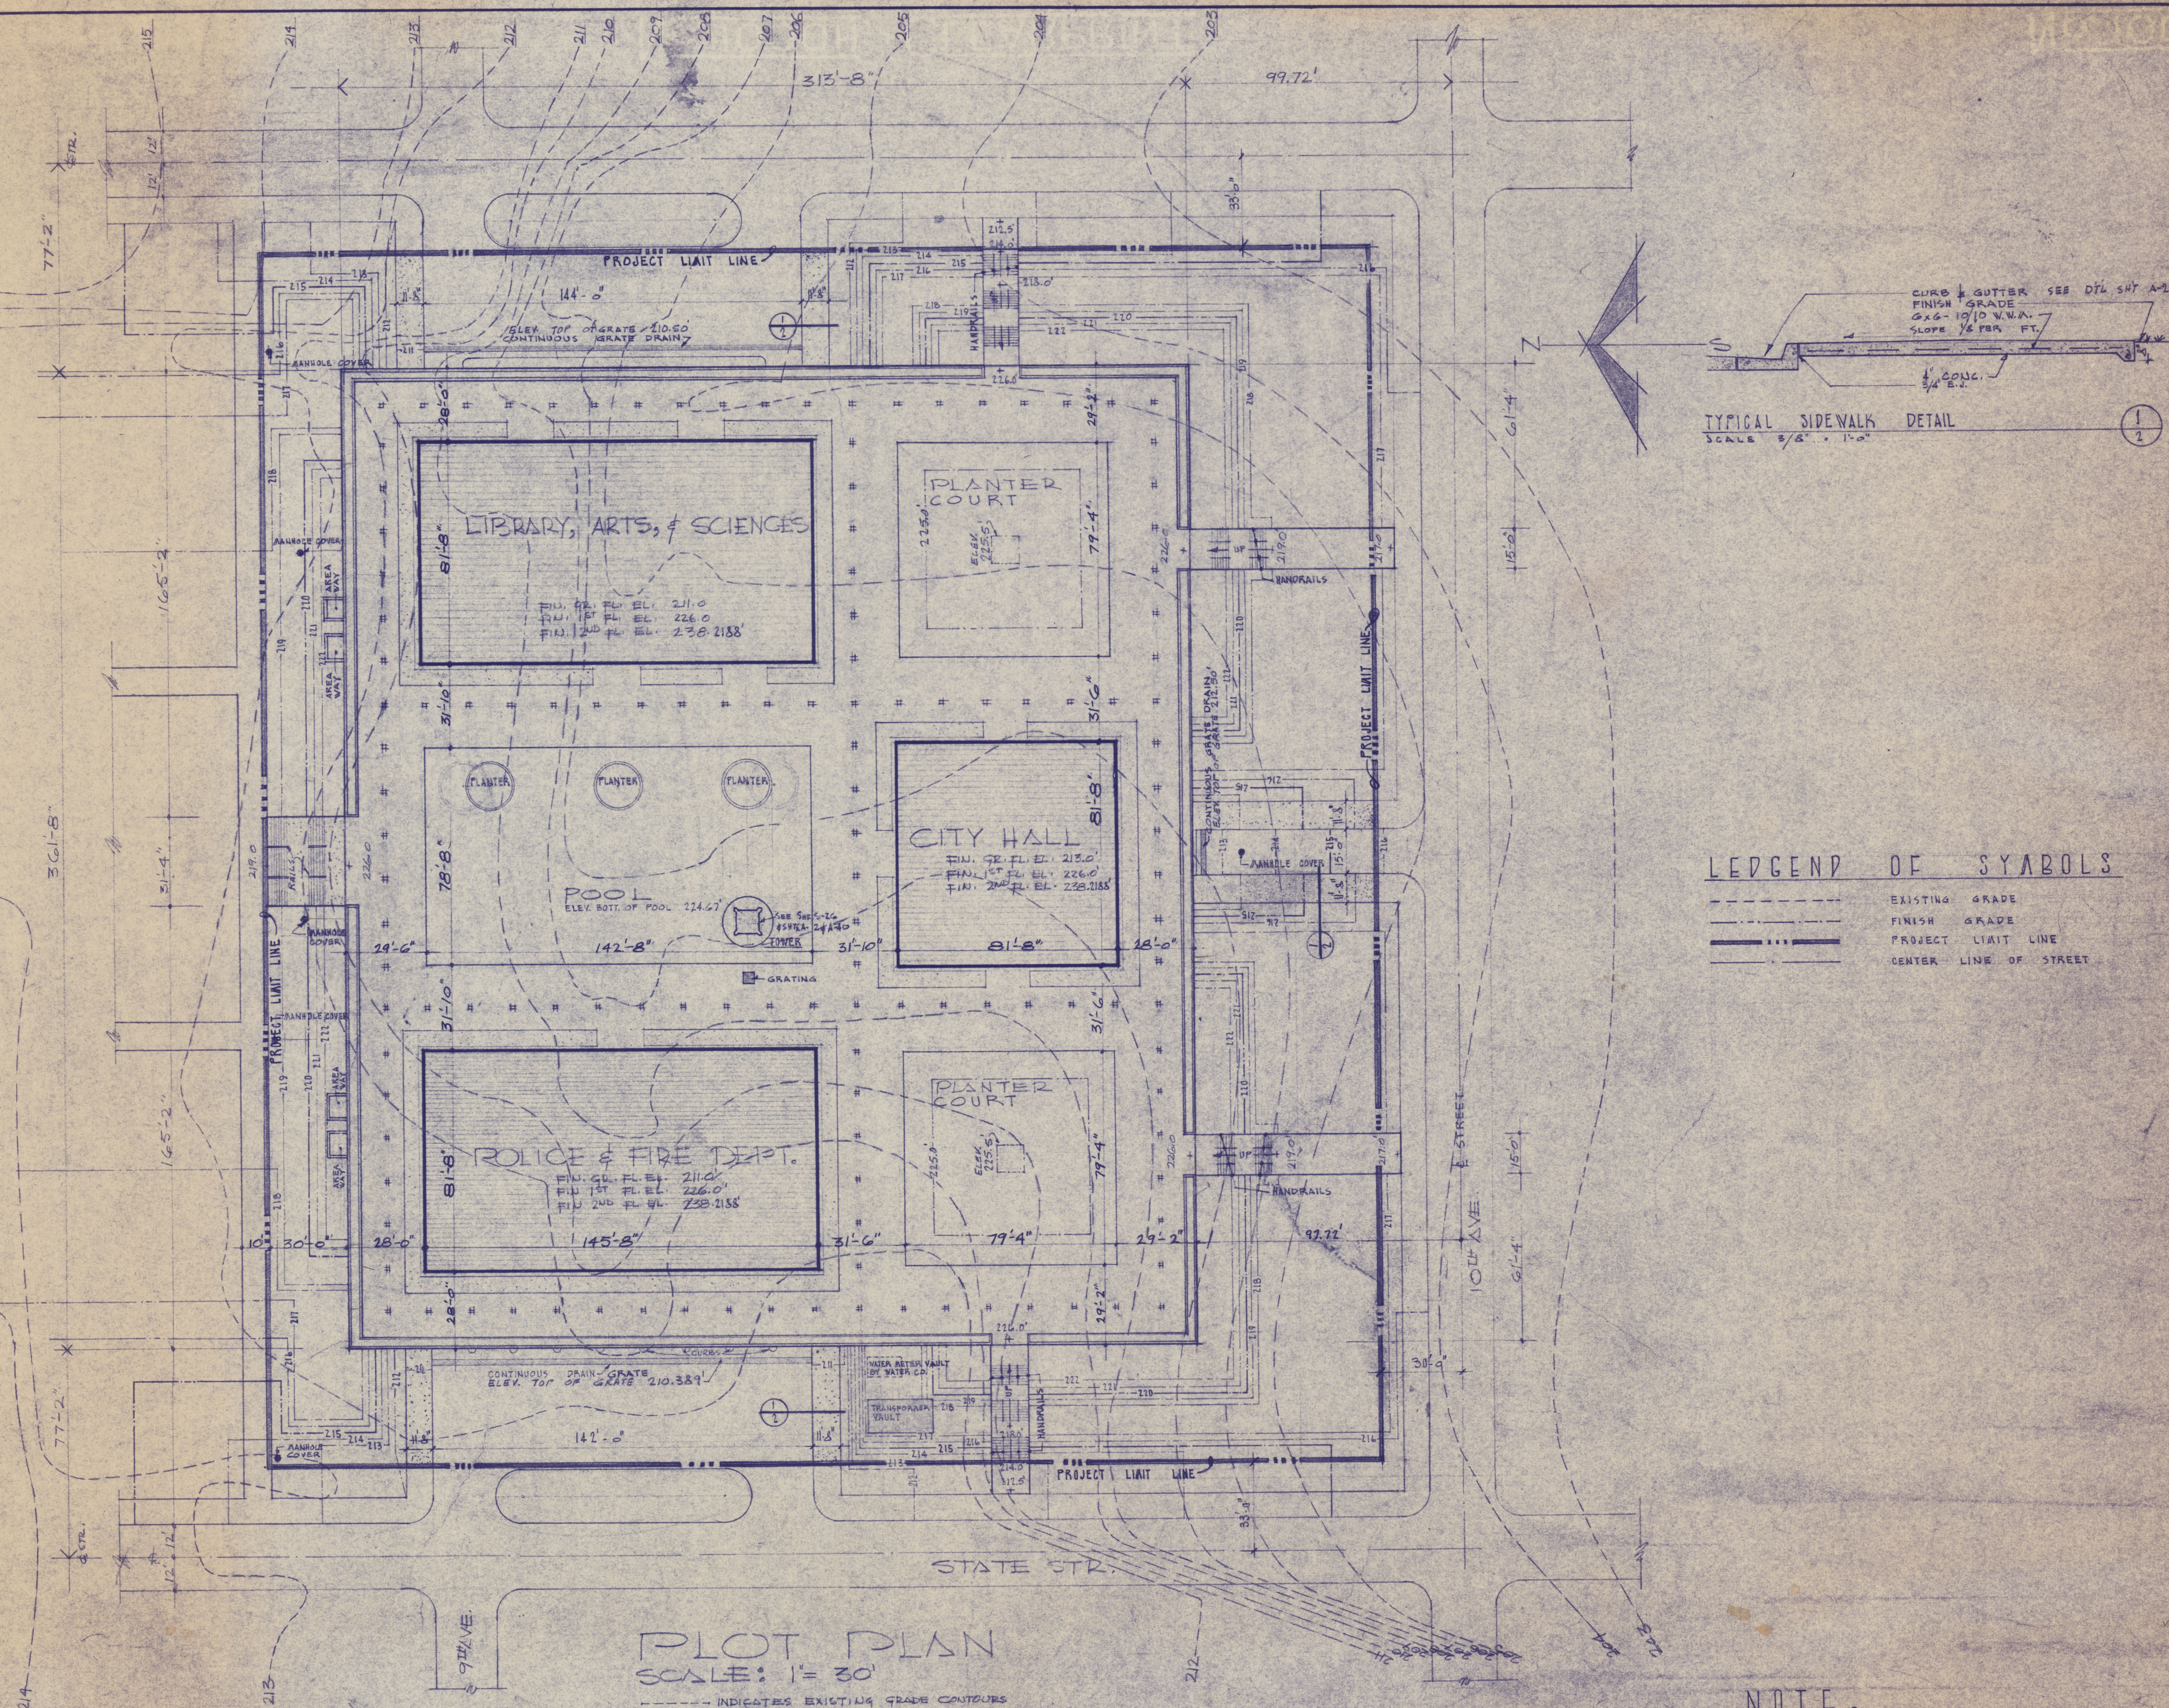

NOTE: THE SCOPE OF THE CONTRACT CONSISTS OF ALL WORK WHICH IS SHOWN INSIDE THE "PROJECT LIMIT LINE", EXCEPTING THAT WORK SHOWN ON MECHANICAL, PLUMBING & ELECTRICAL PLANS BEYOND THIS POINT.